

**GENERAL NOTES:**

1. DRAWINGS (PLANS, DETAILS AND SCHEMATICS ARE DIAGRAMMATIC IN NATURE AND INDICATE GENERAL LOCATION AND ARRANGEMENT OF NEW AND EXISTING MAJOR EQUIPMENT AND PIPING SYSTEMS. CONTRACTOR SHALL BE RESPONSIBLE FOR VERIFYING EXACT LOCATIONS AND DIMENSIONS OF ALL EQUIPMENT, PIPING AND PIPING COMPONENTS. CONTRACTOR IS ALSO RESPONSIBLE FOR FINAL TIE-IN POINT LOCATIONS BETWEEN NEW AND EXISTING PIPING SYSTEMS EQUIPMENT AND UTILITIES.

2. UNLESS OTHERWISE NOTED EXISTING SHOWN IN FADE-AWAY PEN, NEW, RELOCATED OR DEMOLITION ITEMS SHOWN IN DARK HEAVY PEN.


3. SEE CIVIL DRAWINGS FOR UTILITIES AND UNDERGROUND SERVICES.

4. CAP CONDUIT WATER TIGHT ON ALL EXPOSED CONDUIT.

**NOTES:**

(1) MOUNT "A" LIGHT FIXTURE TO BOTTOM OF CEILING FURLIN (TYP).

**01 FMB WEST LIGHTING FLOOR PLAN**  
SCALE: 1/16"=1'-0"

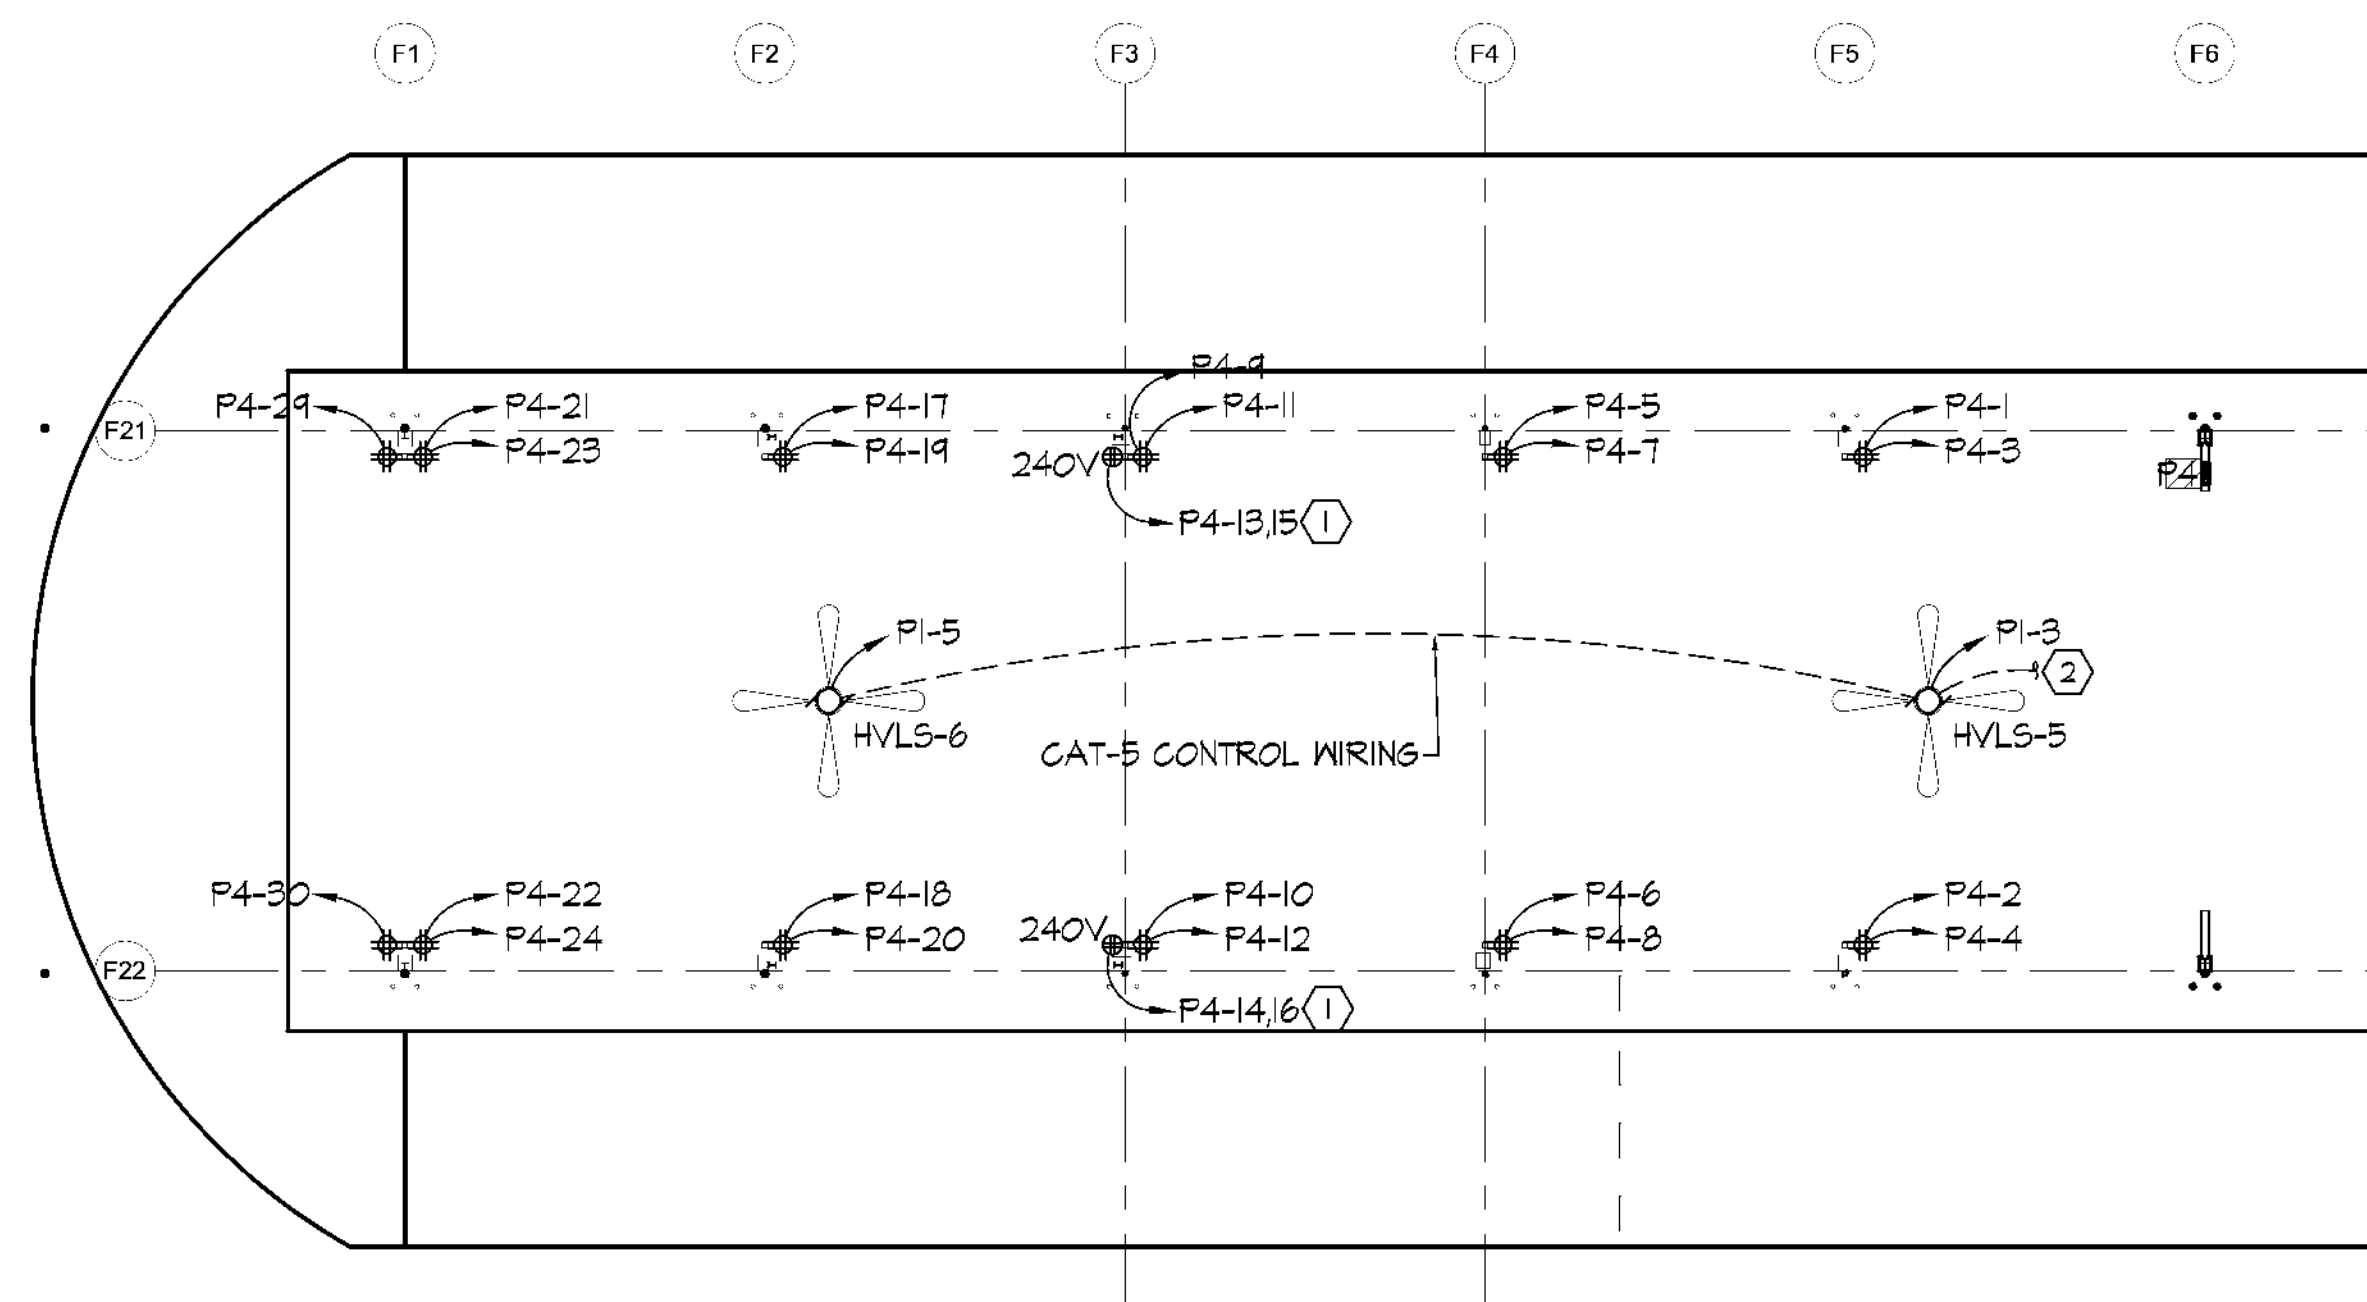

**GENERAL NOTES:**

1. DRAWINGS (PLANS, DETAILS AND SCHEMATICS ARE DIAGRAMMATIC IN NATURE AND INDICATE GENERAL LOCATION AND ARRANGEMENT OF NEW AND EXISTING MAJOR EQUIPMENT AND PIPING SYSTEMS. CONTRACTOR SHALL BE RESPONSIBLE FOR VERIFYING EXACT LOCATIONS AND DIMENSIONS OF ALL EQUIPMENT, PIPING AND PIPING COMPONENTS. CONTRACTOR IS ALSO RESPONSIBLE FOR FINAL TIE-IN POINT LOCATIONS BETWEEN NEW AND EXISTING PIPING SYSTEMS EQUIPMENT AND UTILITIES.

2. UNLESS OTHERWISE NOTED EXISTING SHOWN IN FADE-AWAY PEN, NEW, RELOCATED OR DEMOLITION ITEMS SHOWN IN DARK HEAVY PEN.

3. SEE CIVIL DRAWINGS FOR UTILITIES AND UNDERGROUND SERVICES.


4. CAP CONDUIT WATER TIGHT ON ALL EXPOSED CONDUIT.

**NOTES:**

(1) 2 #6 THHN, #10 CU GRD, 3" C BACK TO A 50A, 2P BRKR.

(2) CAT-5 CONTROL WIRING TO NETWORK CONTROLLER.

**02 FMB WEST POWER FLOOR PLAN**  
SCALE: 1/16"=1'-0"

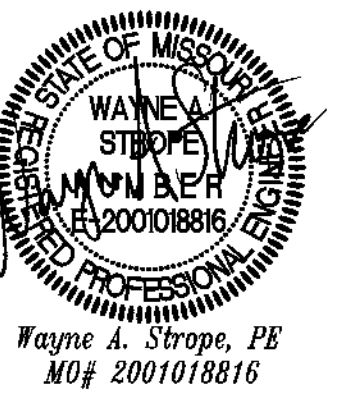

Architecture

Interior Design

Planning

Sustainability

2801 Woodard Drive, Suite 103  
Columbia, MO 65202  
573.443.1407

www.soa-inc.com

Missouri Certificate of  
Authority Number: 000826

**MEP ENGINEER:**



2801 Woodard Drive, Suite 103  
Columbia, MO 65202  
573.443.1407

**CIVIL & STRUCTURAL:**



1901 Pennsylvania Dr.  
Columbia, MO 65202  
573.814.1568

City of Columbia Parks and Recreation Department

**Clary Shy Agriculture Park**

1751, 1769, & 1857 WEST ASH ST  
COLUMBIA, MO 65203

**ISSUE FOR PERMIT**

October 19, 2017

REVISION DATE

**FMB WEST LIGHTING  
AND POWER**

**E5.01**

PROJECT #17015

If you must print this drawing, please  
recycle.

JOB# 17015 FMB 10/17/2017