

- ### SIGN TYPE LEGEND
- ▶ RI - ROOM IDENTITY - REFER TO B4 / G-135
 - ▷ TR - TOILET ROOM IDENTITY - REFER TO A4 / G-135
 - EV EV - EVACUATION PLAN - REFER TO A1 / G-135
 - TE - TACTILE EXIT SIGN - REFER TO A3 / G-135
 - SFA SFA - SPRINKLER FIRE ALARM - REFER TO A2 / G-135
 - IN-# IN - INFORMATIONAL SIGN - REFER TO A2 / G-135
 - EES EES - ELEVATOR EMERGENCY SIGN
 - X BN - BUILDING NUMBER ON SIGN - REFER TO C4 / G-135

- ### SIGNAGE SCHEDULE GENERAL NOTES
- PROVIDE SIGN OVER EACH FIRE EXTINGUISHER AND AED. REFER TO B3/G-135 FOR DETAIL. REFER TO LIFE SAFETY PLANS AND FLOOR PLANS FOR LOCATIONS OF FIRE EXTINGUISHERS AND AED'S.

- ### SIGNAGE SCHEDULE REMARKS
- TITLE AND NAME WILL BE CONFIRMED TO CONTRACTOR BY MISSOURI ARMY NATIONAL GUARD AT TIME OF SHOP DRAWING DEVELOPMENT.
 - CONFIRM MESSAGE WITH MISSOURI ARMY NATIONAL GUARD AT TIME OF SHOP DRAWING DEVELOPMENT.
 - MECHANICALLY FASTENED EXTERIOR SIGN.
 - INTERIOR SIGN ADHESIVELY APPLIED TO FINISHED GYPSUM BOARD OR CMU.
 - INTERIOR SIGN ADHESIVELY APPLIED TO GLAZING. PROVIDE BACK PLATE ON OPPOSITE SIDE OF GLAZING.


ROOM NUMBER	MESSAGE (WHERE OCCURS)	SIGN TYPE	BRAILLE	REMARKS
B202	TO BE DETERMINED	R1	*	2, 5
B205	TO BE DETERMINED	R1	*	2, 4
B205B	SUPERVISOR	R1	*	1, 5
B206	TO BE DETERMINED	R1	*	1, 5
B207	TO BE DETERMINED	R1	*	1, 5
B208	COMMANDER	R1	*	1, 5
B210	CONFERENCE ROOM	R1	*	2, 5
B211	MEN	TR	*	4
B212	WOMEN	TR	*	4
B216	BREAK ROOM	R1	*	2, 4
B217	LAUNDRY	R1	*	2, 4
B218	CUSTODIAL	R1	*	2, 4
B219	AQMS	R1	*	2, 4
B220	MAINTENANCE OFFICE	R1	*	2, 4
B221A	MOBILIZATION TRAINING	R1	*	2, 4
B221B	MOBILIZATION TRAINING	R1	*	2, 4
B223	MEN	TR	*	4
B224	WOMEN	TR	*	4
B225	TO BE DETERMINED	R1	*	2, 4
B226	ELECTRICAL	R1	*	2, 4
B230	IT LAB	R1	*	2, 4
B231	TO BE DETERMINED	R1	*	2, 4
B232	SIPR	R1	*	2, 4
B233	TO BE DETERMINED	R1	*	1, 5
B234	TO BE DETERMINED	R1	*	2, 4
B235	SERVER	R1	*	2, 4
B240	ALSE	R1	*	2, 4
B242	FLIGHT OPS	R1	*	2, 4
B243	TO BE DETERMINED	R1	*	1, 5
B244	TO BE DETERMINED	R1	*	1, 5
B245	TO BE DETERMINED	R1	*	1, 5
B246	TO BE DETERMINED	R1	*	1, 5
B247	TO BE DETERMINED	R1	*	1, 5
B248	TO BE DETERMINED	R1	*	1, 5

JACOBS
 501 North Broadway, Saint Louis, Missouri 63102
 TEL: 314.335.4000
 JACOBS ENGINEERING GROUP, INC.
 Missouri State Certificate of Authority #007074
 Consultant - Civil
 MILLENNIA PROFESSIONAL SERVICES OF ILLINOIS, LTD.
 11 Executive Drive, Suite 12
 Fairview Heights, Illinois, 62208
 Tel: 618-824-8610
 Missouri State Certificate of Authority #2012009247

Robert A. Messel, AIA
 Architect
 MO# A-3930

REV	DESCRIPTION	DATE

AVCRAD PHASE 3A ADDITION
 1107th THEATER AVIATION SUSTAINMENT MAINTENANCE GROUP
 MISSOURI ARMY NATIONAL GUARD
 GREENE COUNTY
 SPRINGFIELD, MISSOURI
 CONTRACT NO. T1808-01
 NATIONAL GUARD BUREAU
 NGB PROJECT NO. 290109

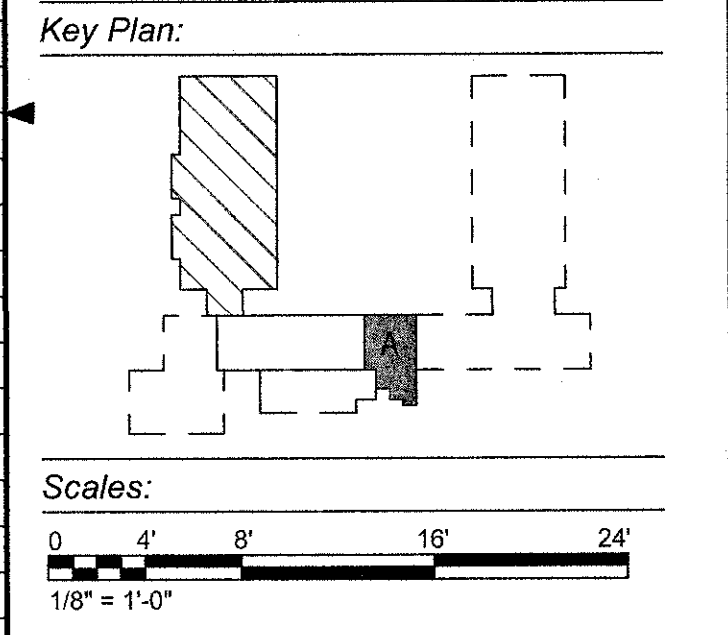

Project No.: T1808-01
 Drawing Title: GENERAL PARTIAL SECOND FLOOR SIGNAGE PLAN - AREA A
 Date: 29 JUNE 2018
 Designed: AT
 Drawn: NF
 Checked: RY
 Drawing No.: G-134
 14 of 322

JACOBS PROJECT NO. F3W91001
 7/30/2018 1:45:27 PM BIM_360/us-f3w91000-TASMG-ARCH-MOD/RING_TASMG-ARCH-V17.rvt

A1
 PARTIAL SECOND FLOOR SIGNAGE PLAN - AREA A
 1/8" = 1'-0"