


GENERAL NOTES


1. REFER TO DRAWING M-001 AND M-002 FOR SYMBOLS, ABBREVIATIONS, AND GENERAL NOTES.

JACOBS
 501 North Broadway, Saint Louis, Missouri 63102
 TEL: 314.335.4000
 JACOBS ENGINEERING GROUP, INC.
 Missouri State Certificate of Authority #000704
 Consultant - Civil
 MILLENNIA PROFESSIONAL SERVICES OF ILLINOIS, LTD
 11 Executive Drive, Suite 12
 Fairview Heights, Illinois 62208
 Tel: 618-624-8610
 Missouri State Certificate of Authority #2012009247

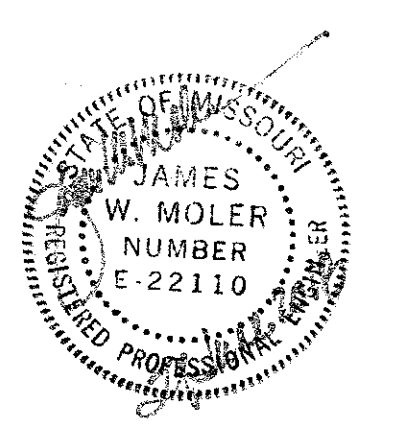

James W. Moler, PE
 Mechanical
 MO# E-22110


REV	DESCRIPTION	DATE

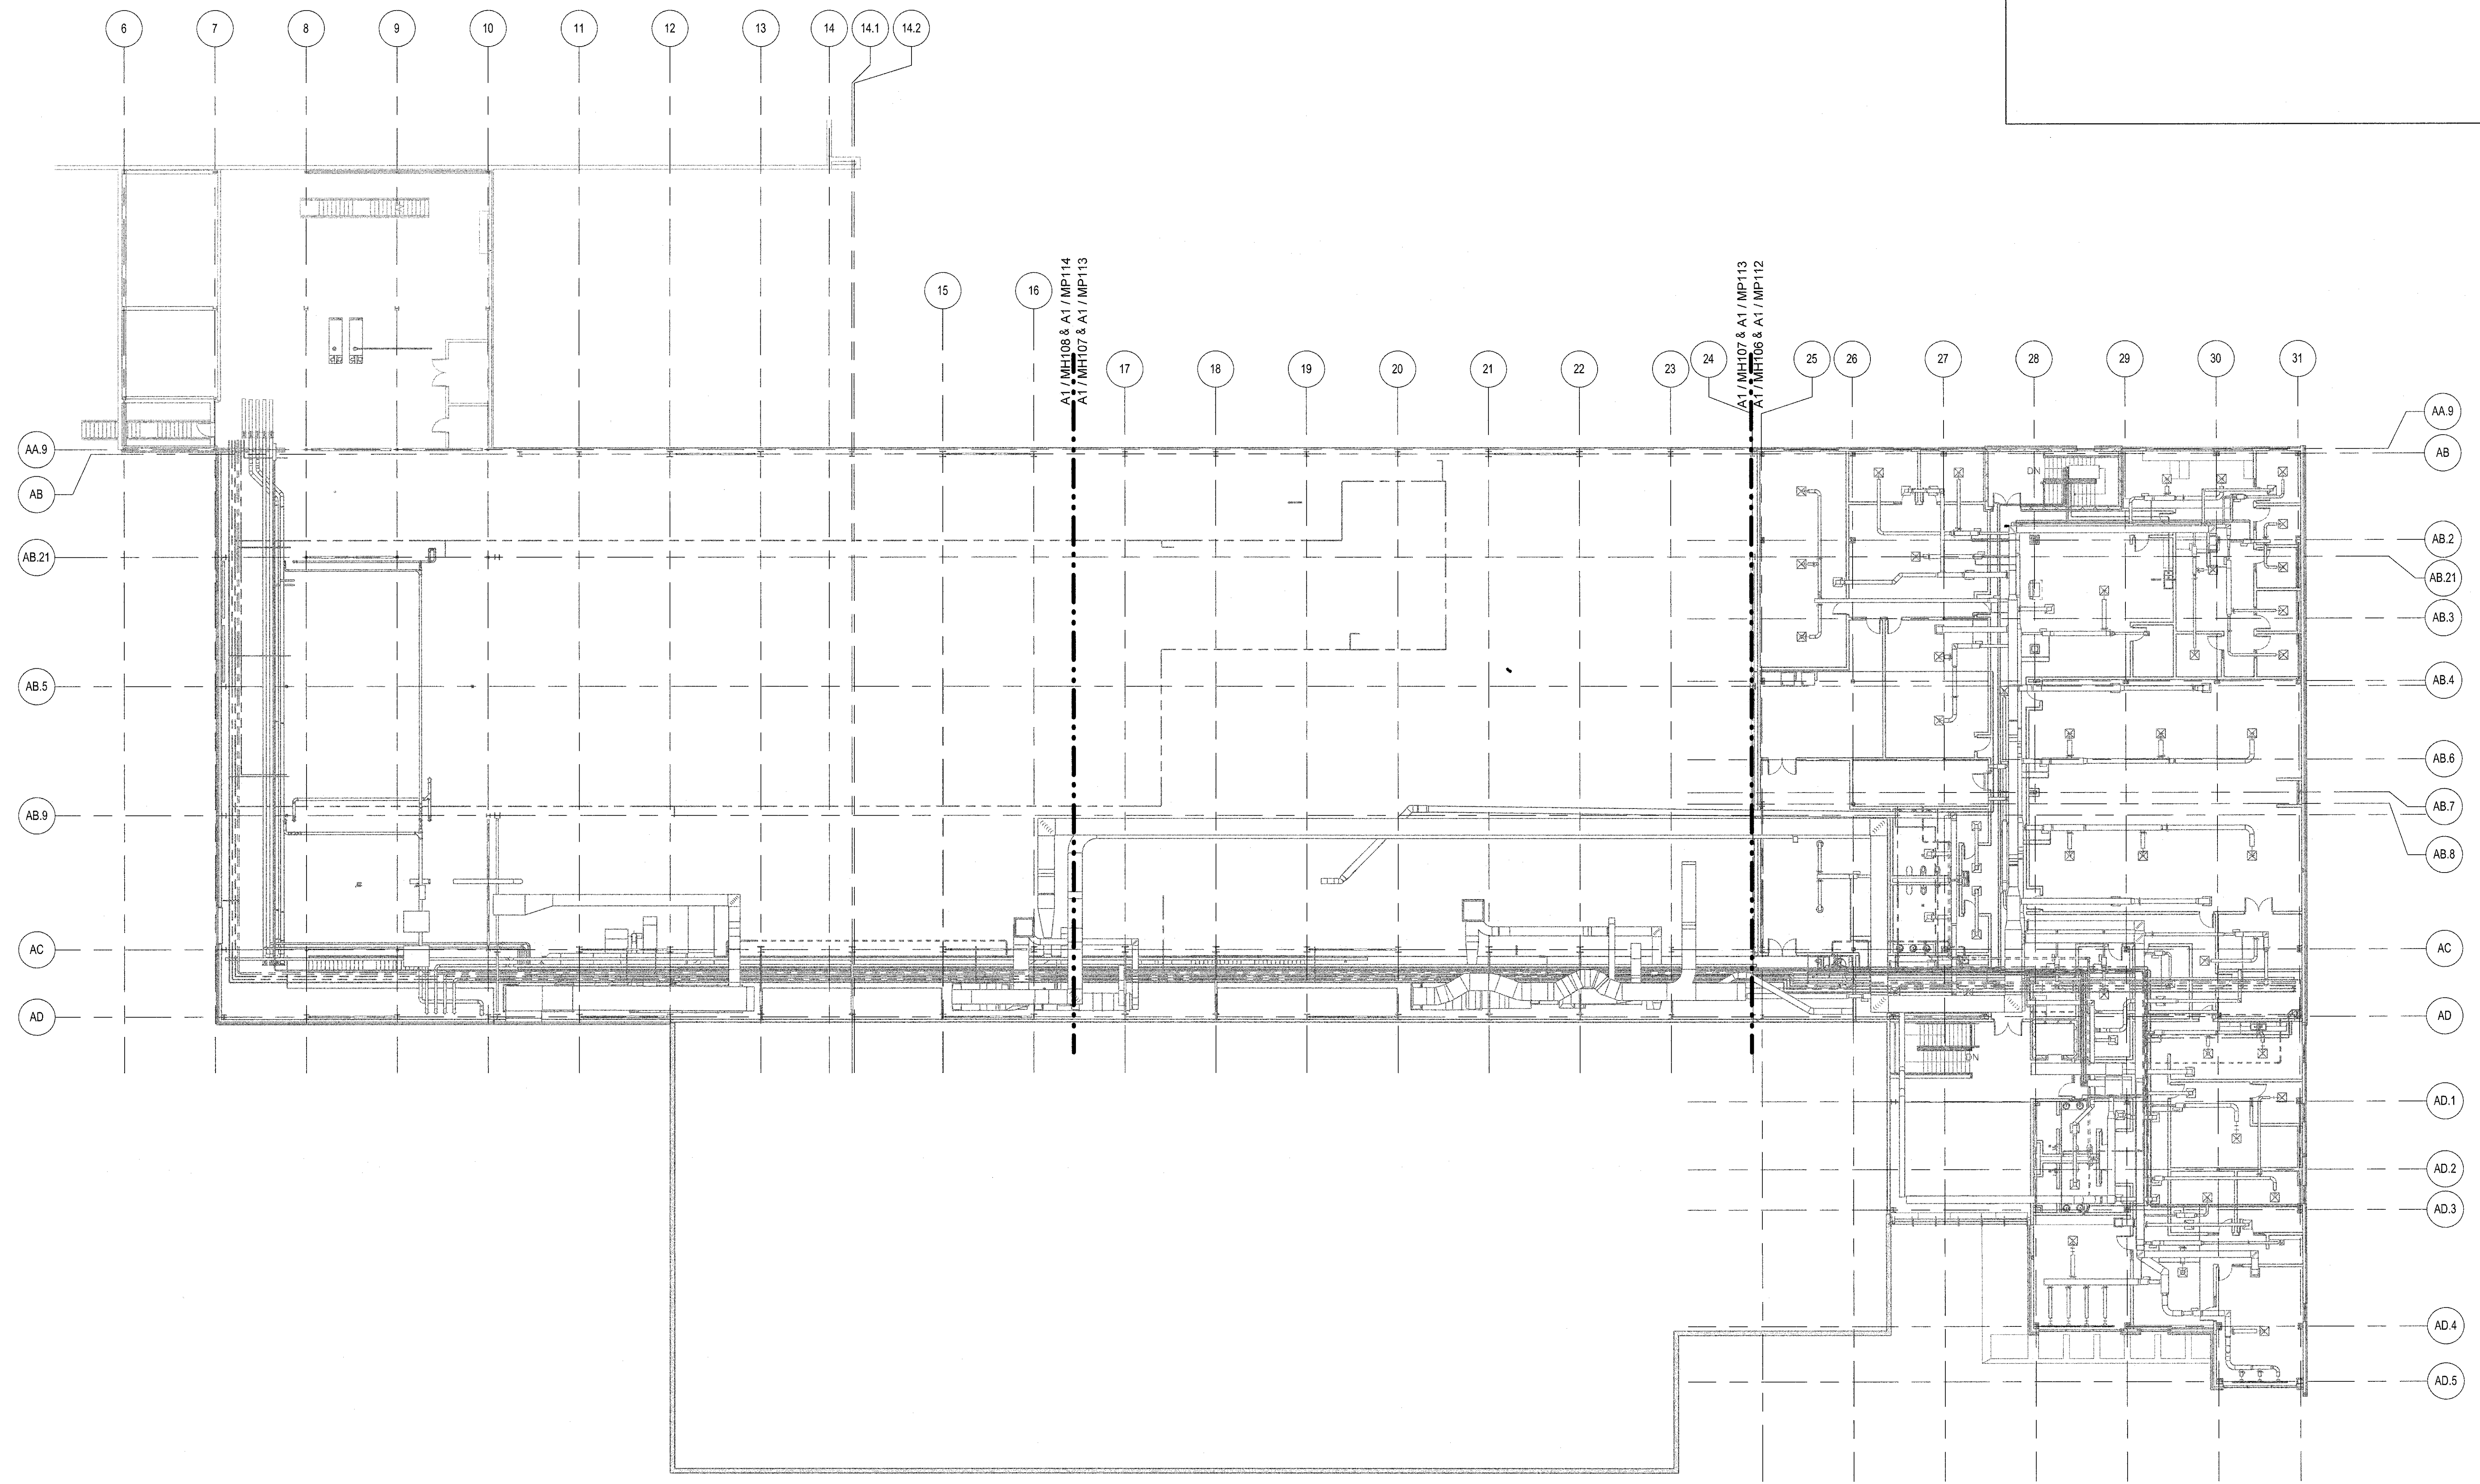


A1 / MH108 & A1 / MP114
 A1 / MH107 & A1 / MP113

A1 / MH107 & A1 / MP113
 A1 / MH108 & A1 / MP112

AVCRAD PHASE 3A ADDITION
 1107th THEATER AVIATION SUSTAINMENT MAINTENANCE GROUP
 MISSOURI ARMY NATIONAL GUARD
 GREENE COUNTY
 SPRINGFIELD, MISSOURI
 CONTRACT NO. T1808-01
 NATIONAL GUARD BUREAU
 NGB PROJECT NO. 290109

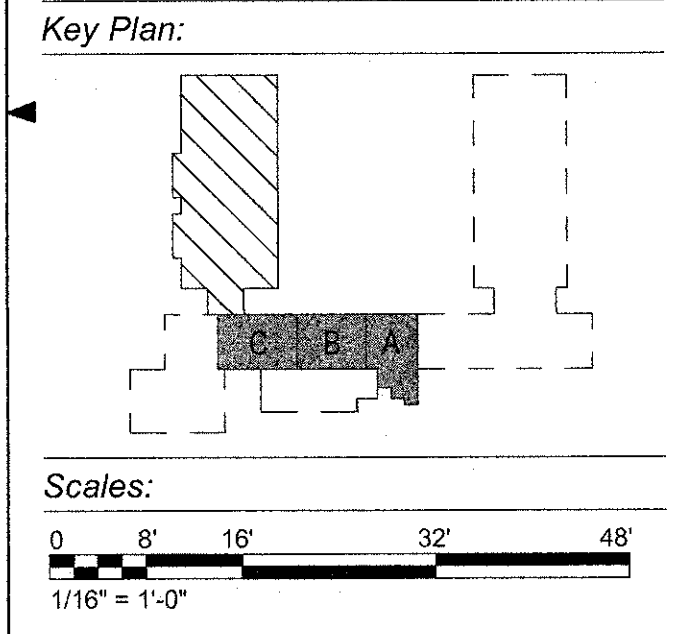

A1 OVERALL SECOND FLOOR PLAN
 1/16" = 1'-0"

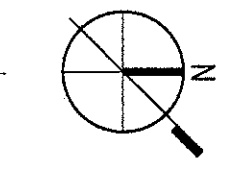

Project No.: T1808-01
 Drawing Title:
**MECHANICAL
 OVERALL SECOND FLOOR
 PLAN**
 Date: 29 JUNE 2018
 Designed: JC
 Drawn: KP
 Checked: TN
 Drawing No.:
M-102
 237 of 322

JACOBS PROJECT NO. F3W91001
 BIM 360/US F3W91000-TASMG-ARCH/MORNG TASMG-MECH-V17.rvt
 7/30/2018 11:49:56 AM