


GENERAL NOTES

- REFER TO DRAWING M-001 AND M-002 FOR SYMBOLS, ABBREVIATIONS, AND GENERAL NOTES.
- ANCHOR POINTS SUGGESTED FOR NATURAL FLEXIBILITY ANALYSIS. CONFIRM PIPING EXPANSION, STRESS, AND SUPPORT.

JACOBS
 501 North Broadway, Saint Louis, Missouri 63102
 TEL: 314.335.4000
 JACOBS ENGINEERING GROUP, INC.
 Missouri State Certificate of Authority #000704
 Consultant - Civil
 MILLENNIA PROFESSIONAL SERVICES OF ILLINOIS, LTD.
 11 Executive Drive, Suite 12
 Fairview Heights, Illinois, 62208
 Tel: 618-624-8610
 Missouri State Certificate of Authority #2012009247

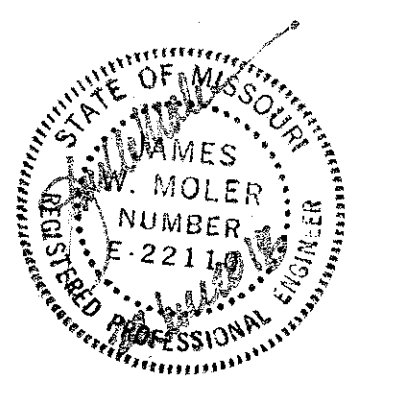


James W. Moler, PE
 Mechanical
 MO# E-22110

REV	DESCRIPTION	DATE

KEYED NOTES

- ROUTE REFRIGERANT LIQUID LINE AND HOT GAS DISCHARGE PIPING FROM AC-1 TO CU-3 PER MANUFACTURER'S RECOMMENDATIONS.
- ROUTE REFRIGERANT LIQUID LINE AND HOT GAS DISCHARGE PIPING FROM AC-2 TO CU-4 PER MANUFACTURER'S RECOMMENDATIONS.

AVCRAD PHASE 3A ADDITION
 1107th THEATER AVIATION SUSTAINMENT MAINTENANCE GROUP
 MISSOURI ARMY NATIONAL GUARD
 GREENE COUNTY
 SPRINGFIELD, MISSOURI
 CONTRACT NO. T1808-01
 NATIONAL GUARD BUREAU
 NGB PROJECT NO. 290109

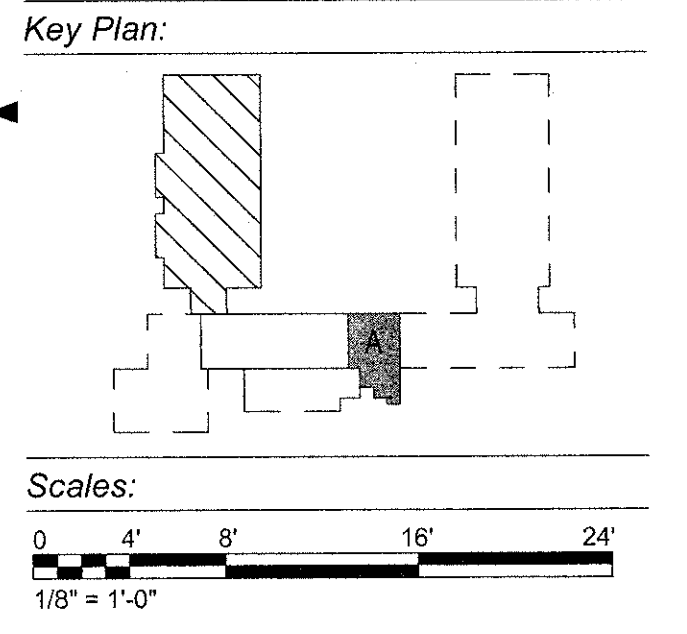

Project No.: T1808-01
 Drawing Title:
MECHANICAL
 PARTIAL FIRST FLOOR
 PIPING PLAN
 AREA A
 Date: 29 JUNE 2018
 Designed: JC
 Drawn: KP
 Checked: TN
 Drawing No.:
MP109
 244 of 322

JACOBS PROJECT NO. F3W91001
 7/30/2018 11:50:09 AM BIM 360://us-f3w91000-tasms-archimcarng-tasms-mech-v17.rvt

A1 PARTIAL FIRST FLOOR PIPING PLAN - AREA A
 1/8" = 1'-0"