

CENTRAL MISSOURI PROFESSIONAL SERVICES, INC.
 CIVIL ENGINEER
 MISSOURI STATE CERTIFICATE OF AUTHORITY # 001558

SSC ENGINEERING, INC.
 MECHANICAL/ELECTRICAL/PLUMBING ENGINEER
 MISSOURI STATE CERTIFICATE OF AUTHORITY # 001244

SSC ENGINEERING, INC.
 STRUCTURAL ENGINEER
 MISSOURI STATE CERTIFICATE OF AUTHORITY # 001244




Missouri State Certificate of Authority # 000143
 631 West Main Street
 Jefferson City, Missouri
 (573) 636-5000 phone

REFLECTED
 CEILING PLAN

MISSOURI SOYBEAN INNOVATION CENTER
 NEW OFFICE BUILDING
 734 S. COUNTRY CLUB DRIVE
 JEFFERSON CITY, MISSOURI

PROJECT NO. 1613
 DATE: SEP. 12, 2018

A701

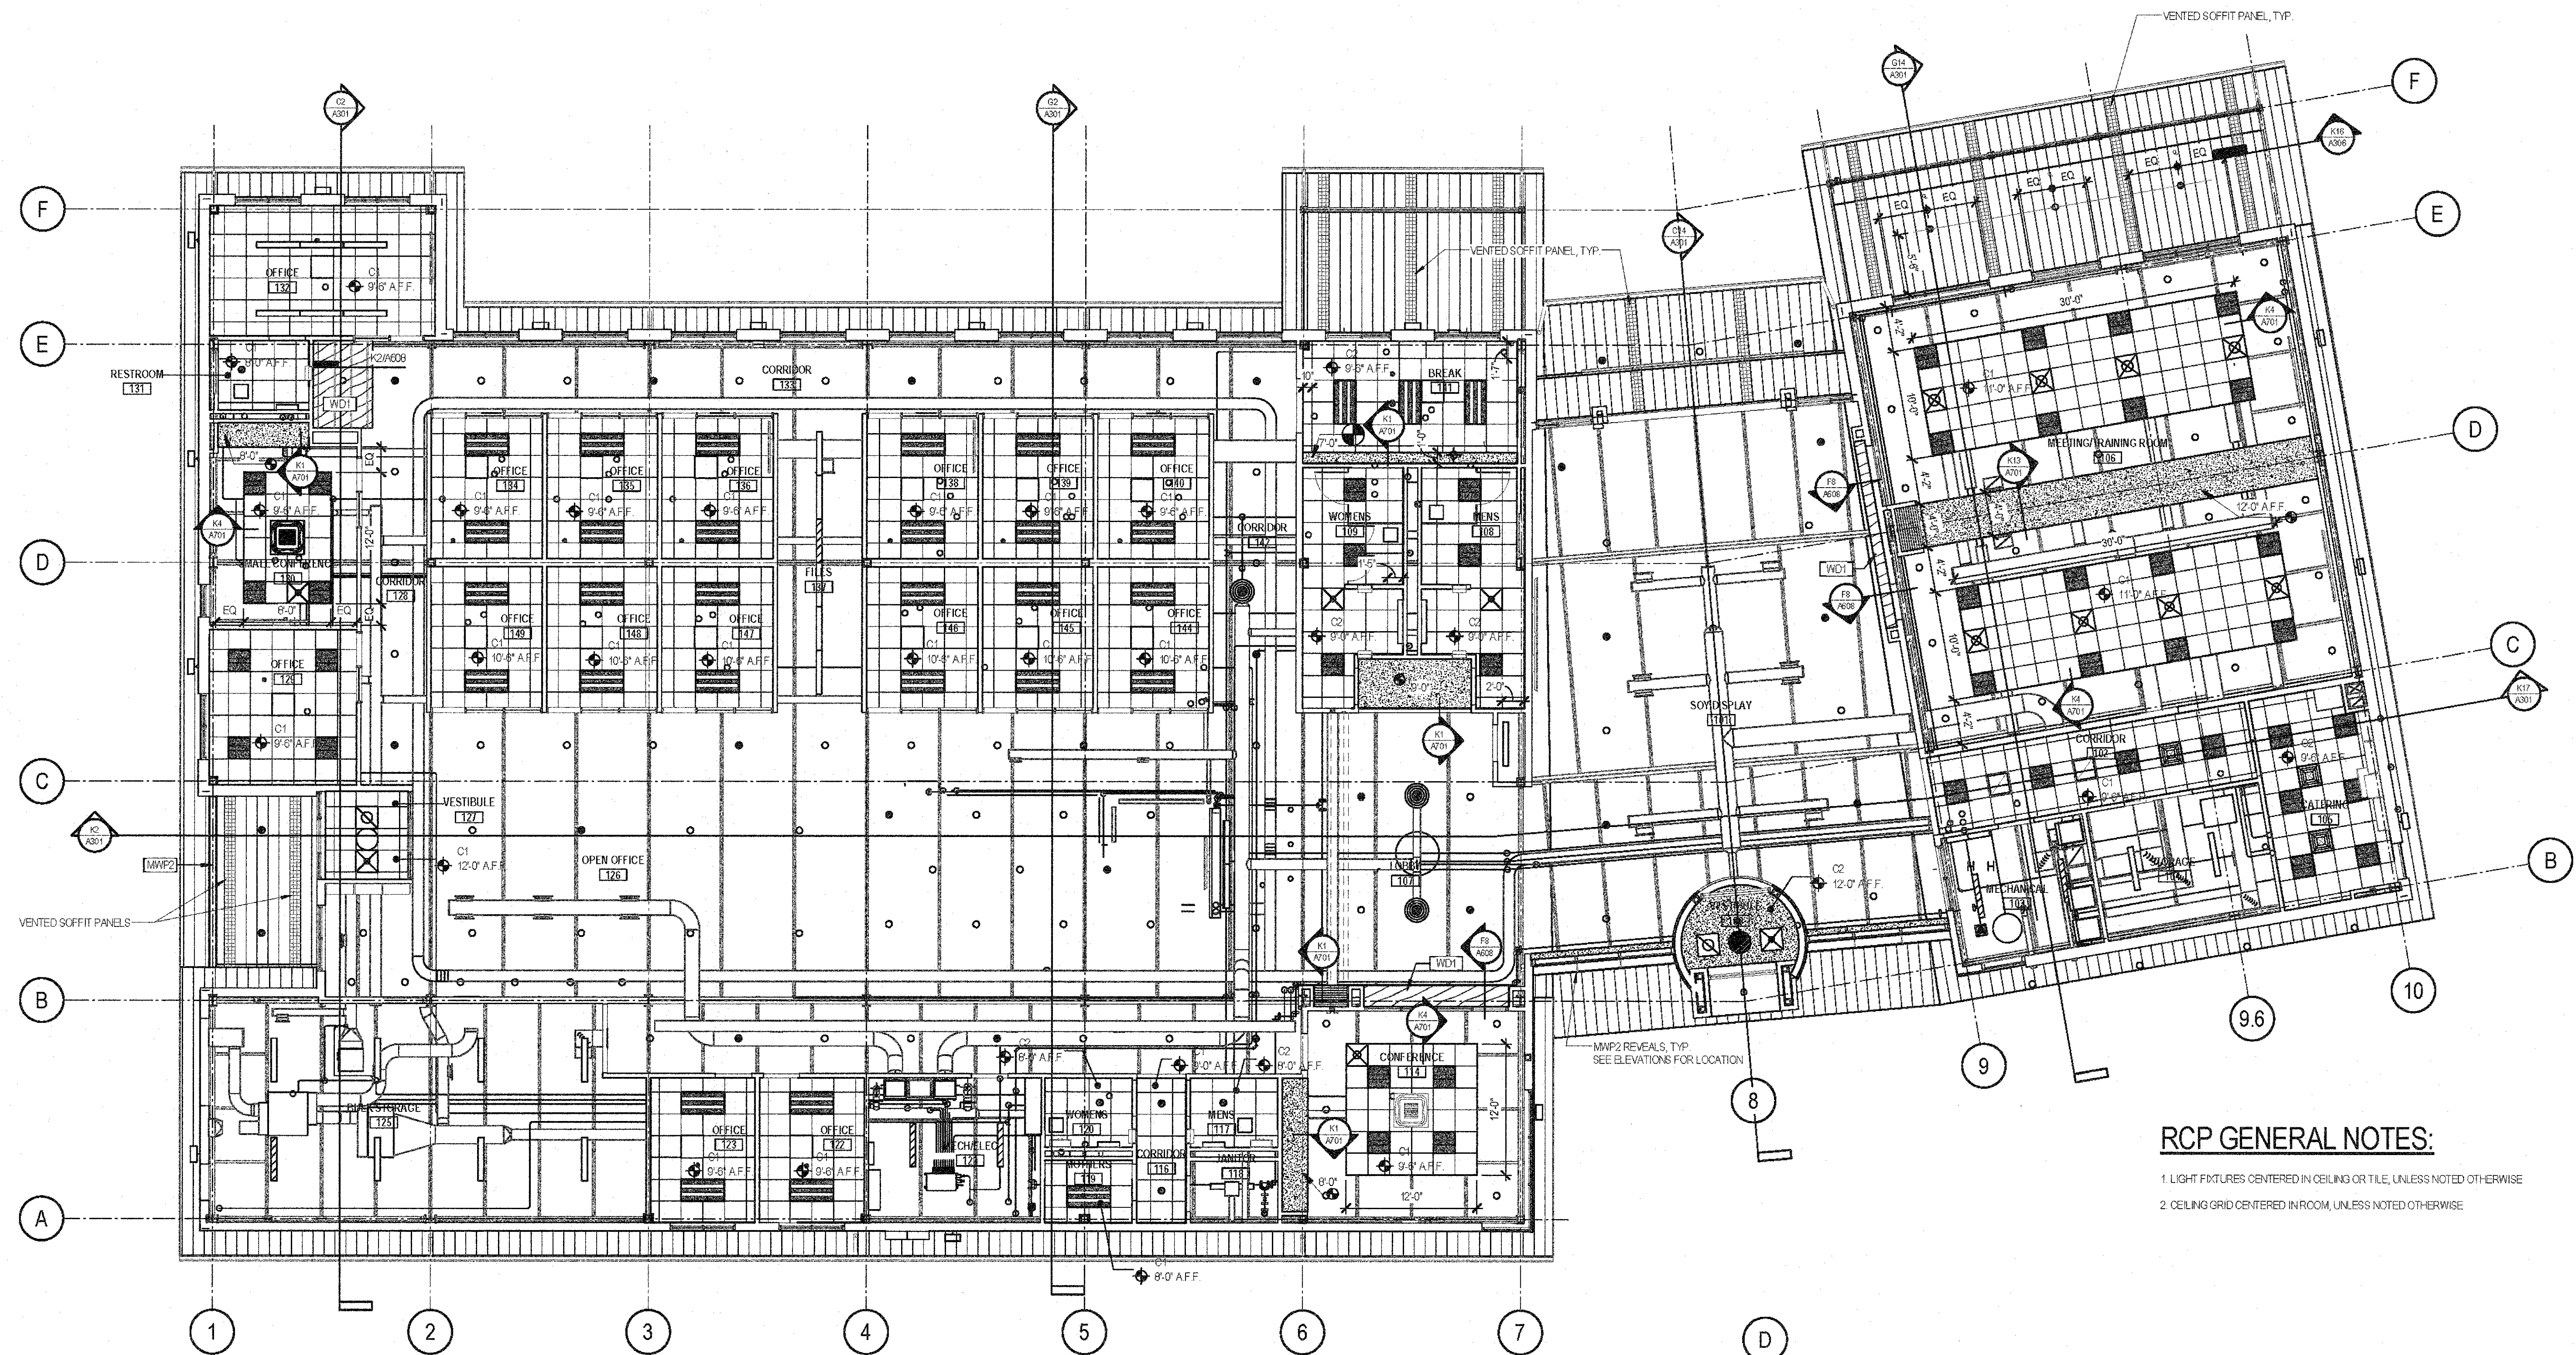

RCP GENERAL NOTES:

- 1. LIGHT FIXTURES CENTERED IN CEILING OR TILE, UNLESS NOTED OTHERWISE
- 2. CEILING GRID CENTERED IN ROOM, UNLESS NOTED OTHERWISE

H2 REFLECTED CEILING PLAN
 SCALE: 1/8" = 1'-0"

