




VRF Riser Diagram  
NOT TO SCALE

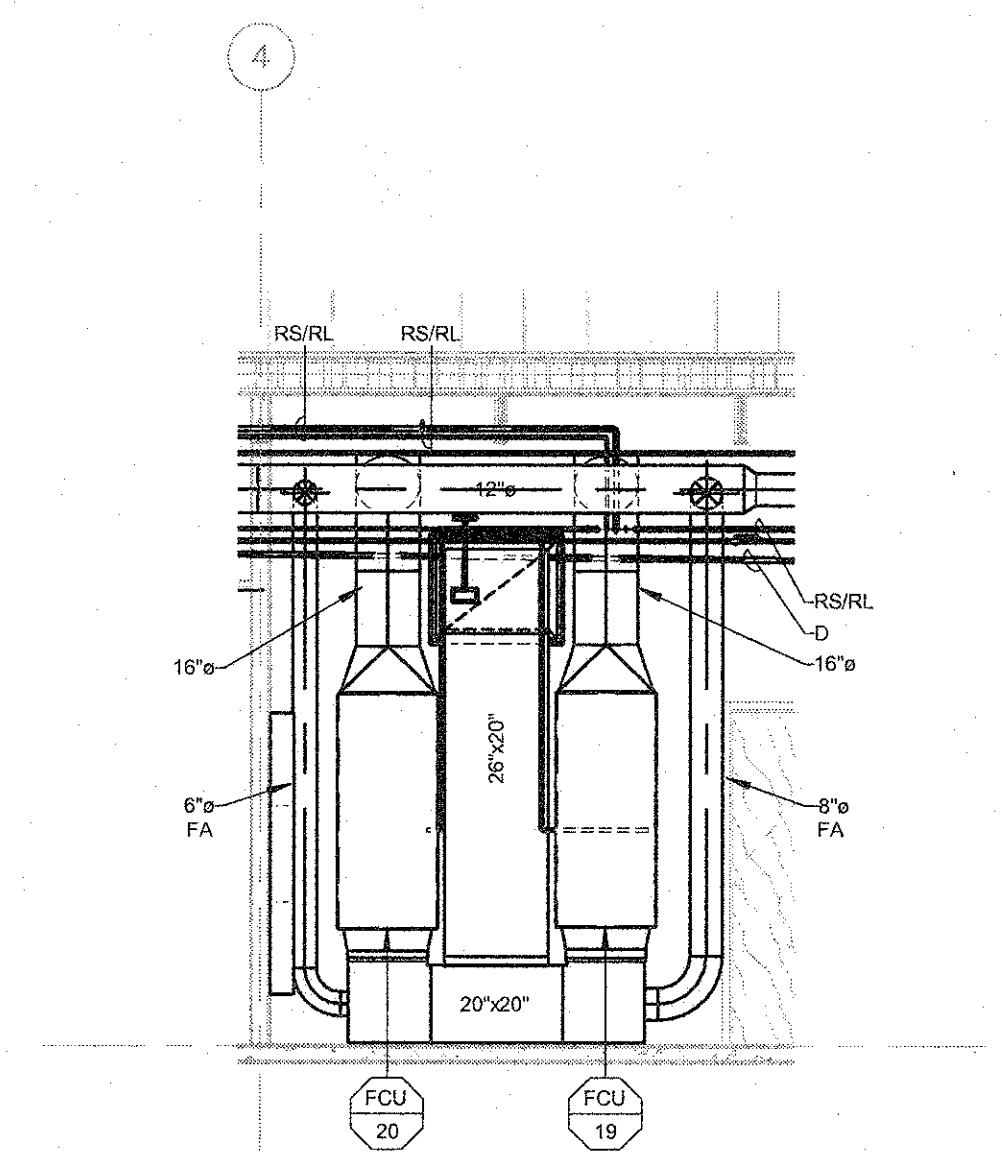


1 SECTION MECH/ELEC 121  
NOT TO SCALE

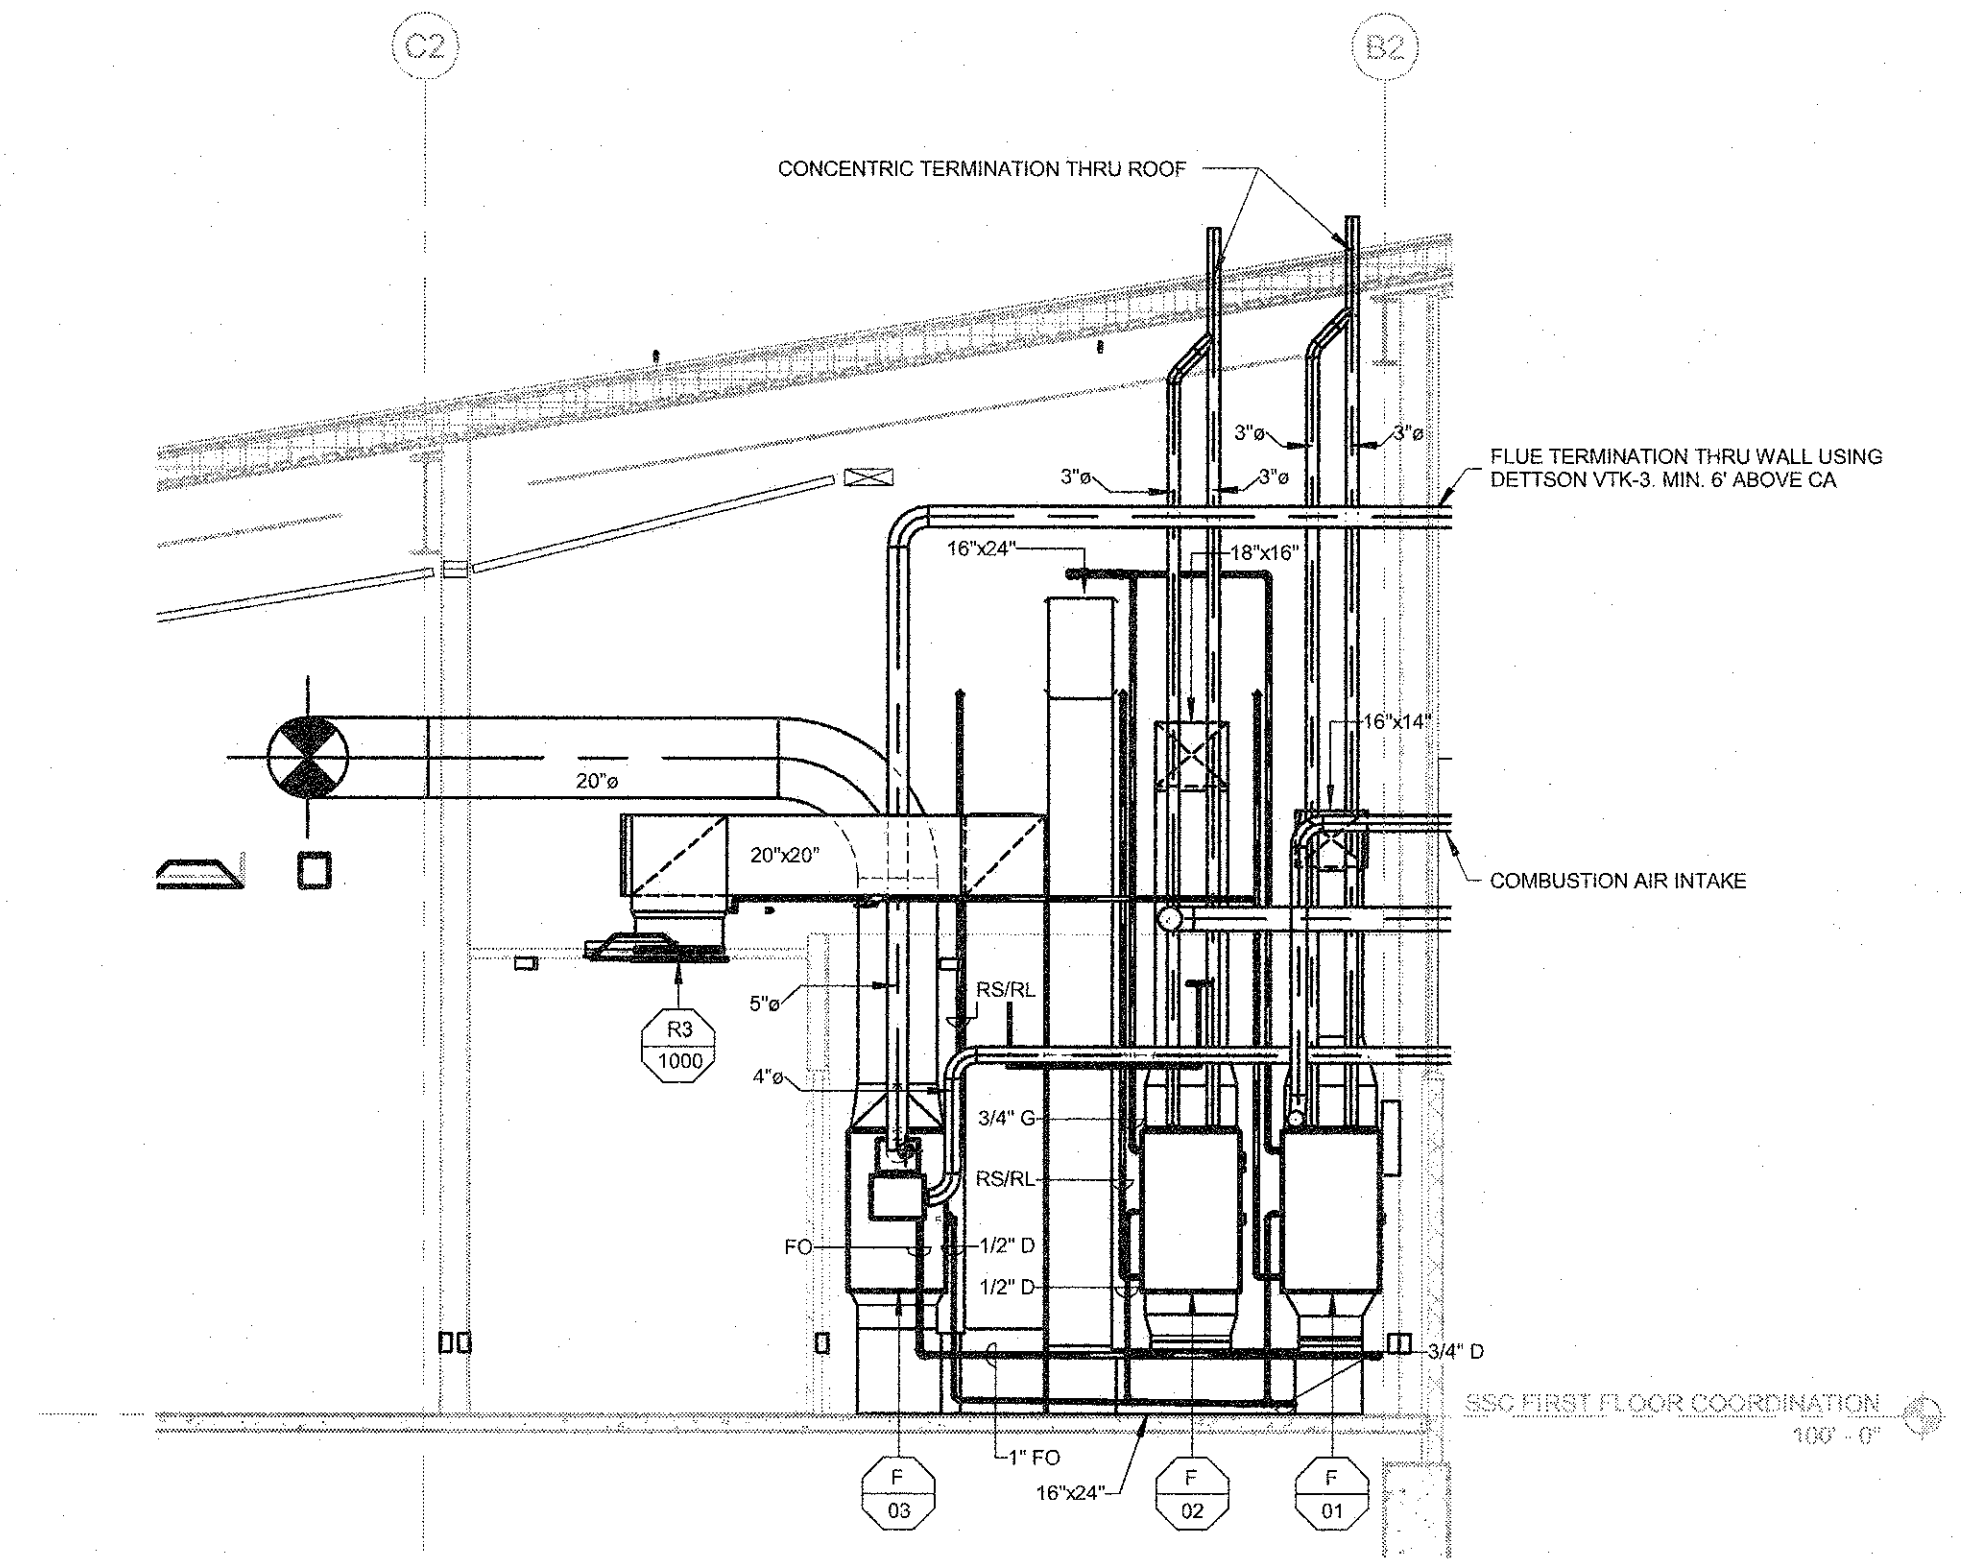

2 SECTION MECHANICAL 103  
SCALE: 1/4" = 1'-0"

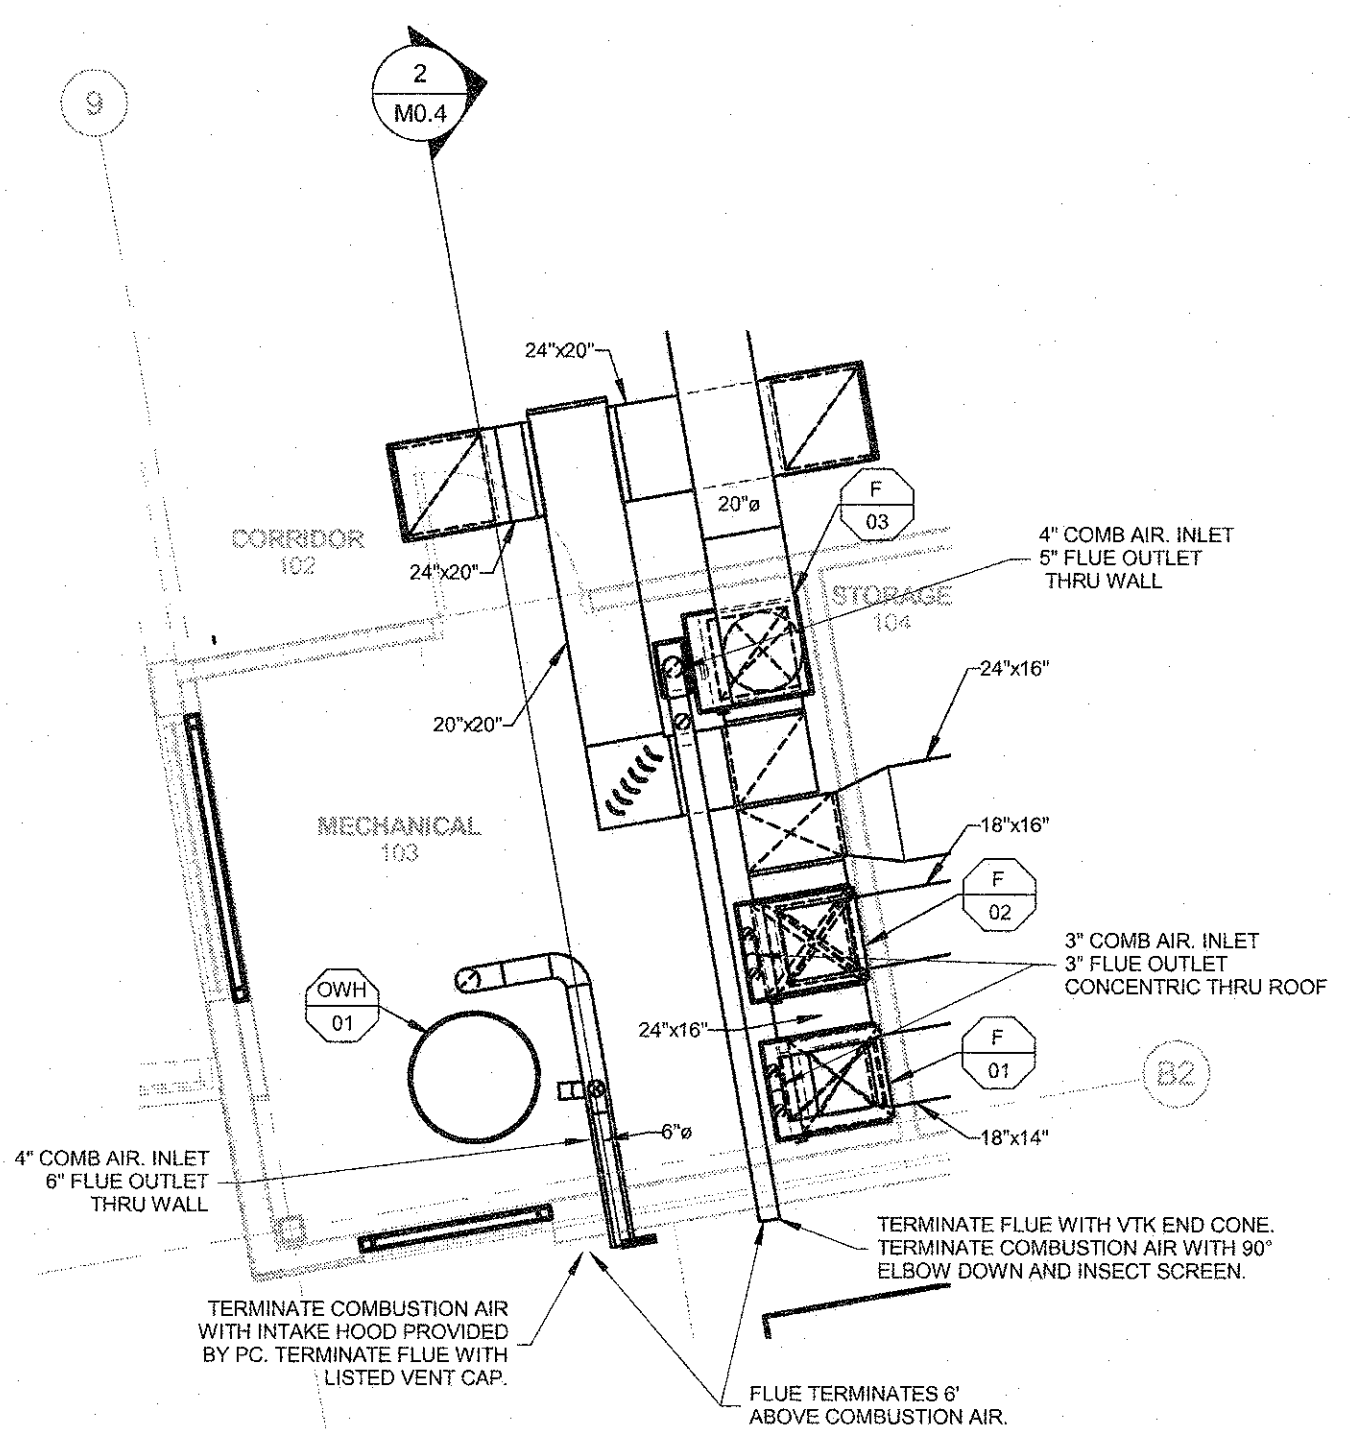


3 ENLARGED MECHANICAL DUCTWORK PLAN  
SCALE: 1/4" = 1'-0"

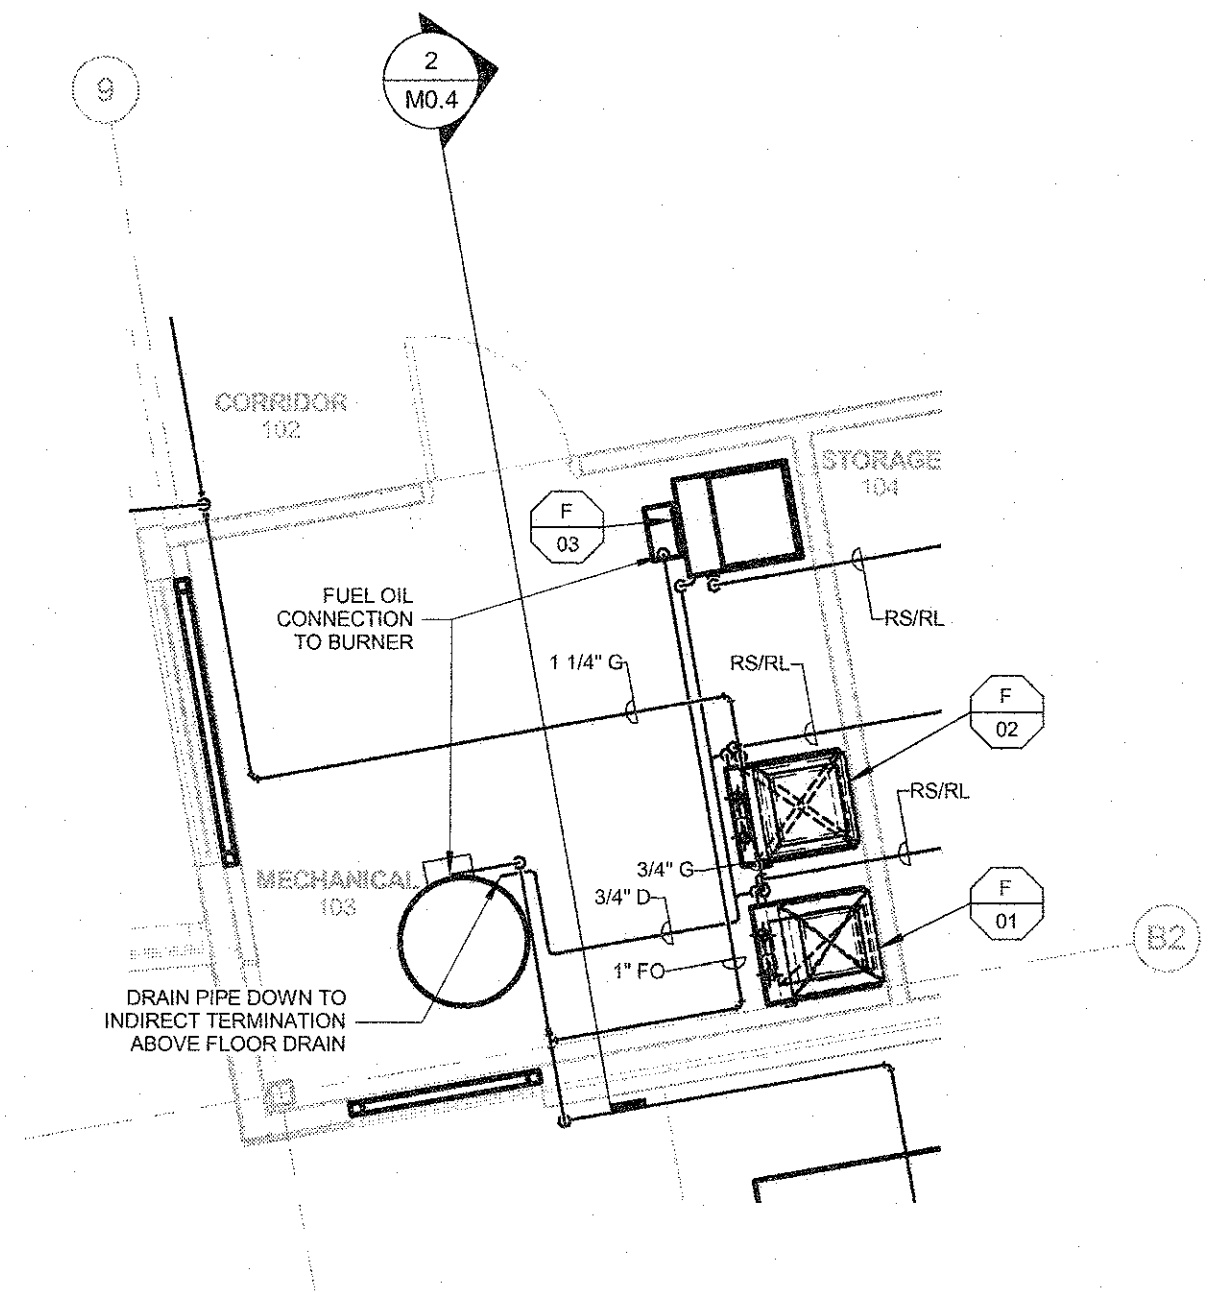

4 ENLARGED MECHANICAL PIPING PLAN  
SCALE: 1/4" = 1'-0"

The Seal and Signature apply only to the Document to which they are Affixed, and Electronic Documents may be used in lieu of the original. Specifications, Estimates, Addendums, and Amendments are to be used for any part or parts of the Document. Copyright © 2018 by SSC Engineering, Inc.

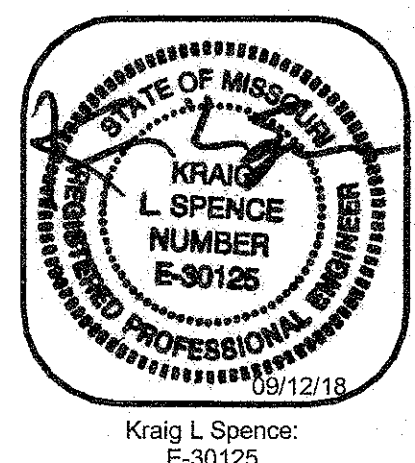

CENTRAL MISSOURI PROFESSIONAL SERVICES, INC.  
 MISSOURI STATE CERTIFICATE OF AUTHORITY #  
 MISSOURI STATE CERTIFICATE OF AUTHORITY #001244  
 MISSOURI STATE CERTIFICATE OF AUTHORITY #001244



MECHANICAL  
 ENLARGED PLANS

**MISSOURI SOYBEAN INNOVATION CENTER**  
**NEW OFFICE BUILDING**  
 734 S. COUNTRY CLUB DRIVE  
 JEFFERSON CITY, MISSOURI

PROJECT NO. 1613  
 DATE: Sept. 12, 2018  
**M0.4**

2017349 - BID/PERMIT SET - 09-12-18